


1 ENLARGED ROOF PLAN - DEMO
1/4" = 1'-0"

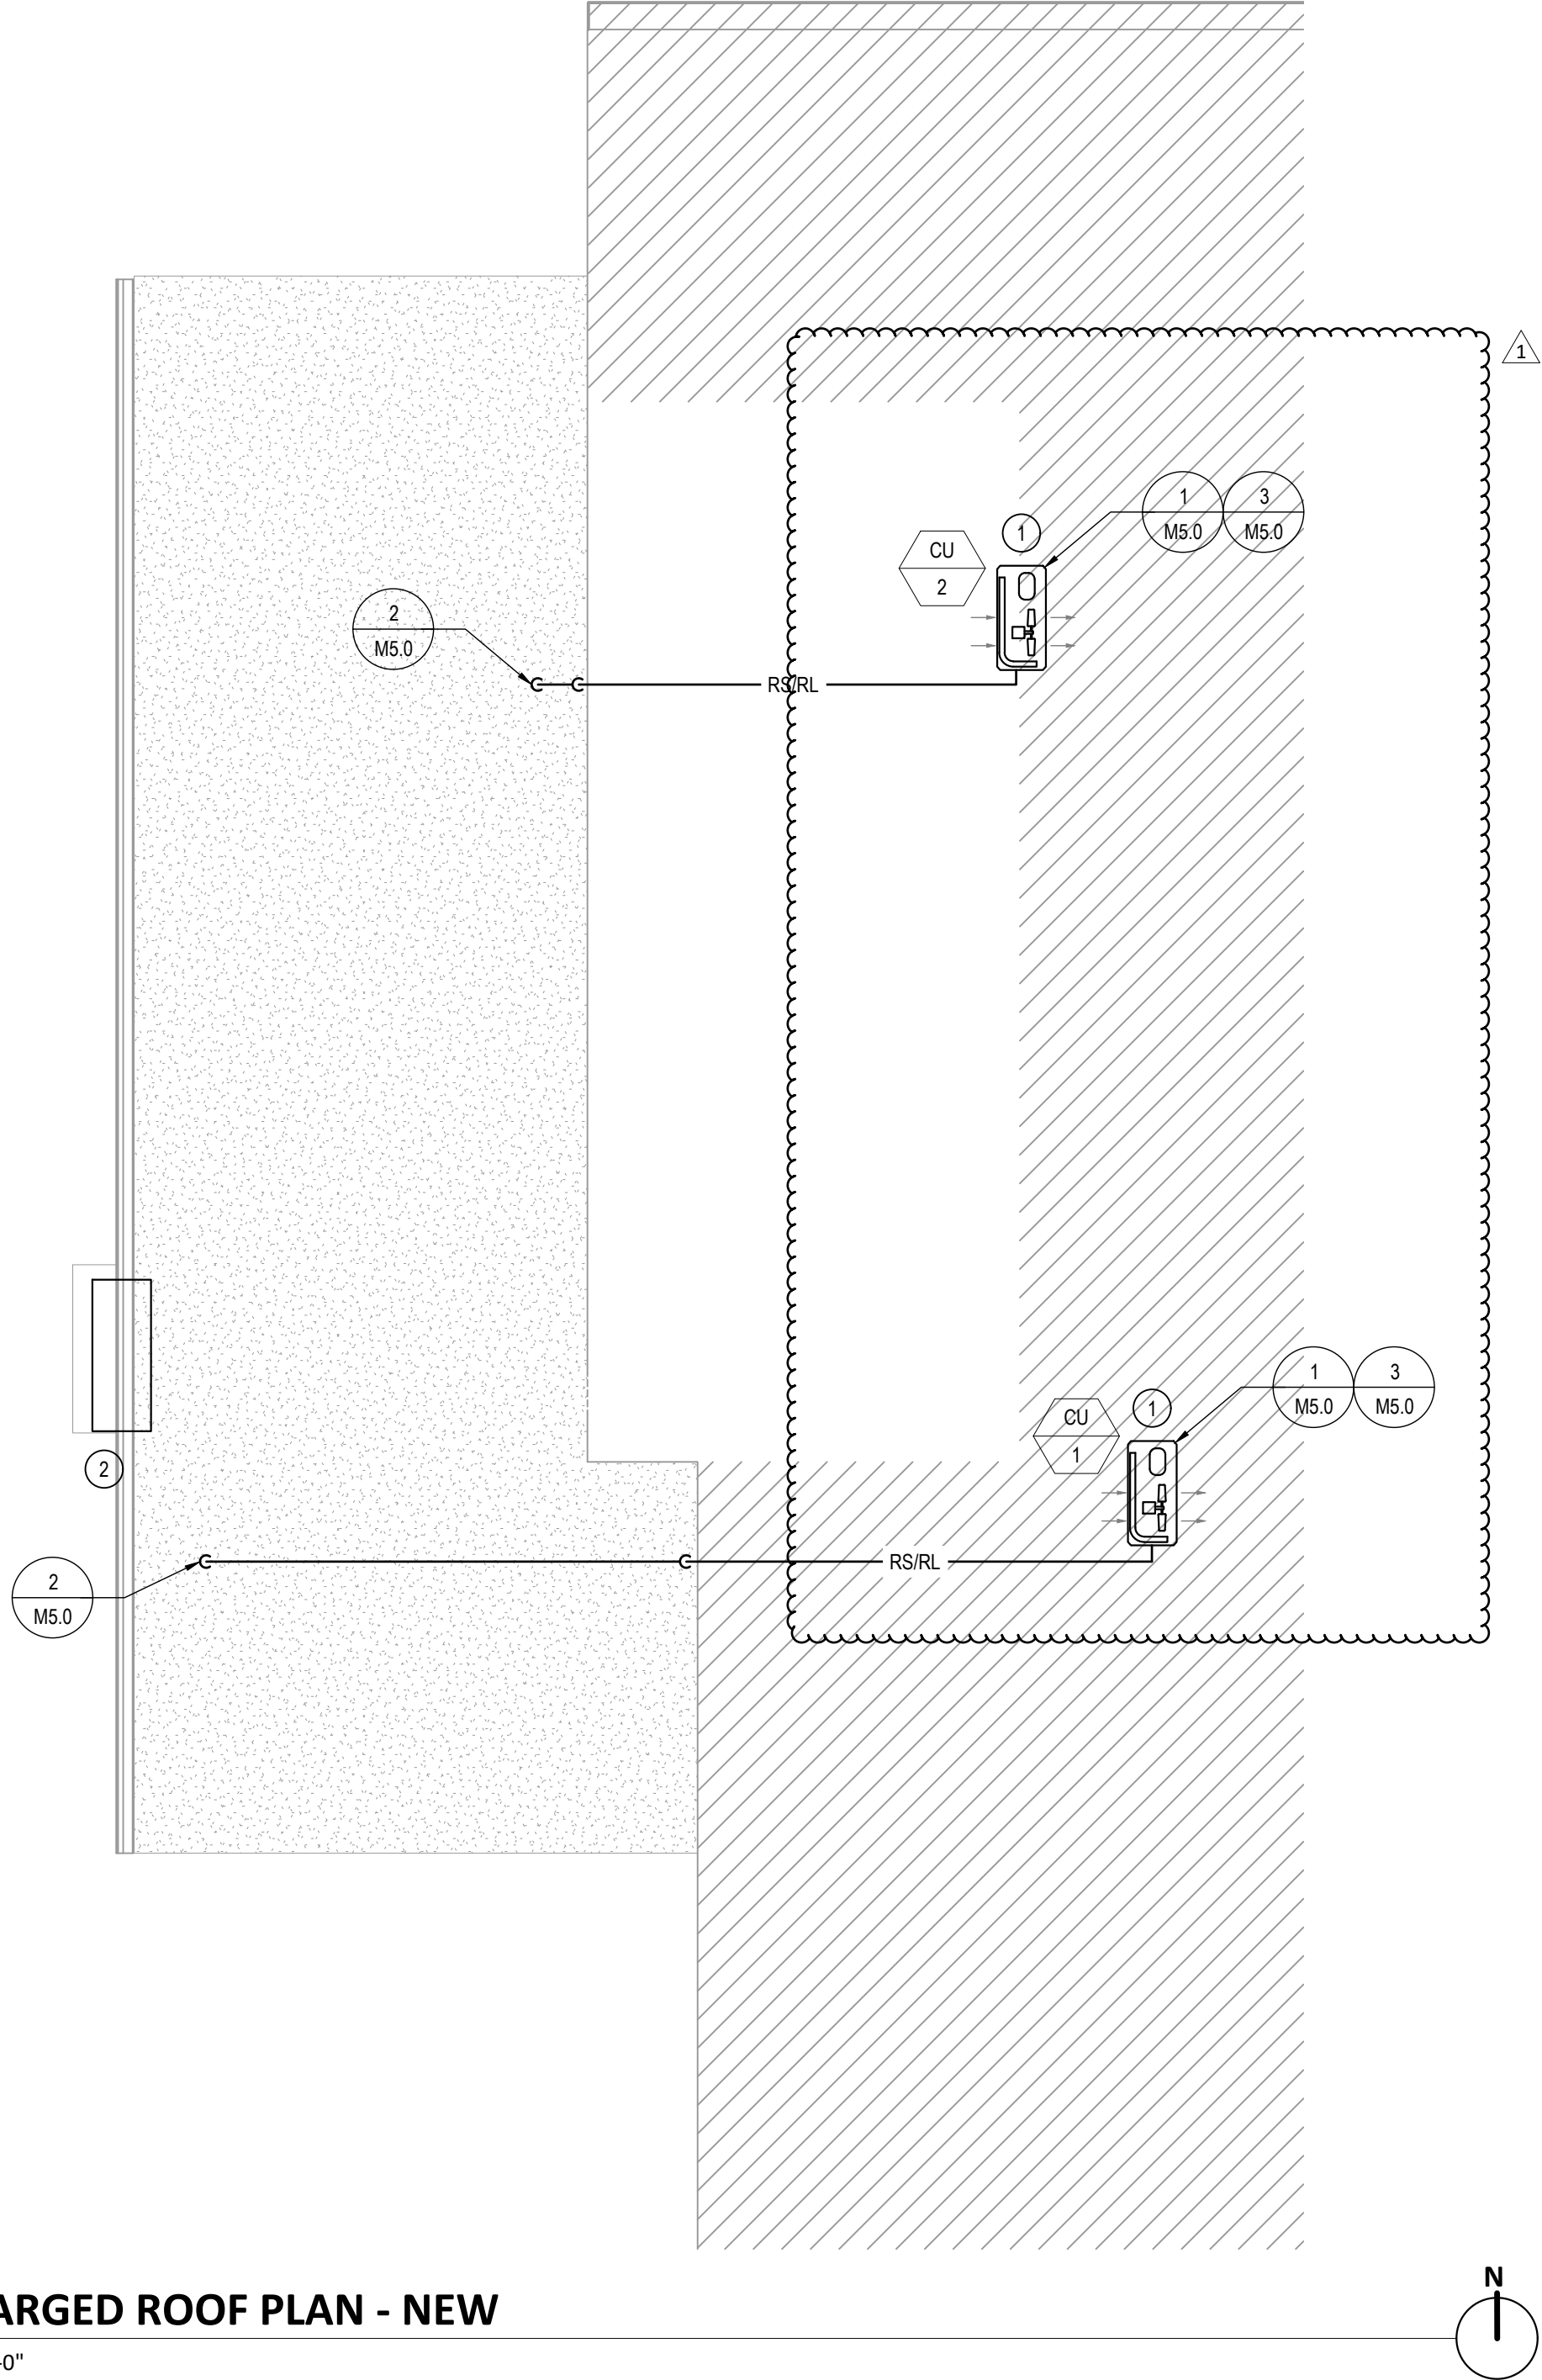

2 ENLARGED ROOF PLAN - NEW
1/4" = 1'-0"

1/4"=1'-0" 0 1 2 3 4 6 8 12

DEMOLITON GENERAL NOTES

1. CONDENSING UNIT AND REFRIGERANT PIPING LOCATIONS ARE APPROXIMATE.

DEMOLITION KEYNOTES

1 DEMO EXISTING CONDENSING UNITS AND REFRIGERANT LINESETS.

GENERAL NOTES

1. INSULATE REFRIGERANT SUCTION LINE. PROVIDE ALUMINUM JACKETING OVER REFRIGERANT PIPING INSULATION.

KEYNOTES

1 APPROXIMATE LOCATION OF CU ON ROOF. LOCATED MIN. 10' FROM EDGE OF ROOF AND AWAY FROM OTHER EXISTING EQUIPMENT.
2 (E) AIR CURTAIN TO BE SALVAGED AND REINSTALLED.

ENLARGED ROOF PLAN - DEMO & NEW

SAN DIEGO UNIFIED SCHOOL DISTRICT
KITCHEN MODIFICATIONS GROUP 6
BELL MIDDLE SCHOOL
620 BRIARWOOD RD,
SAN DIEGO, CA 92139
DSA SUBMITTAL SET

PROJECT NO. SDUF-002
R.S. A.P.

FILE NAME

DATE 04/09/25



REVISIONS
1 04/23/25

SHEET NO.

M4.1

BOARD OF EDUCATION

ob/ARCHITECTURE
2419 EL CAJON BLVD, SAN DIEGO, CA 92104

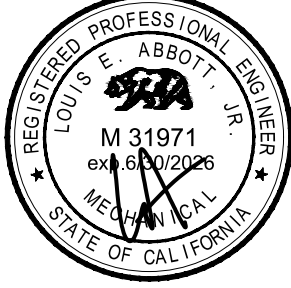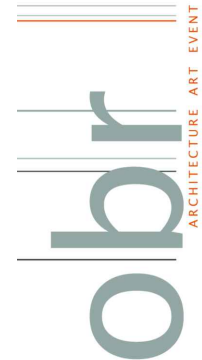

FOR DSA REVIEW ONLY -
NOT FOR CONSTRUCTION

